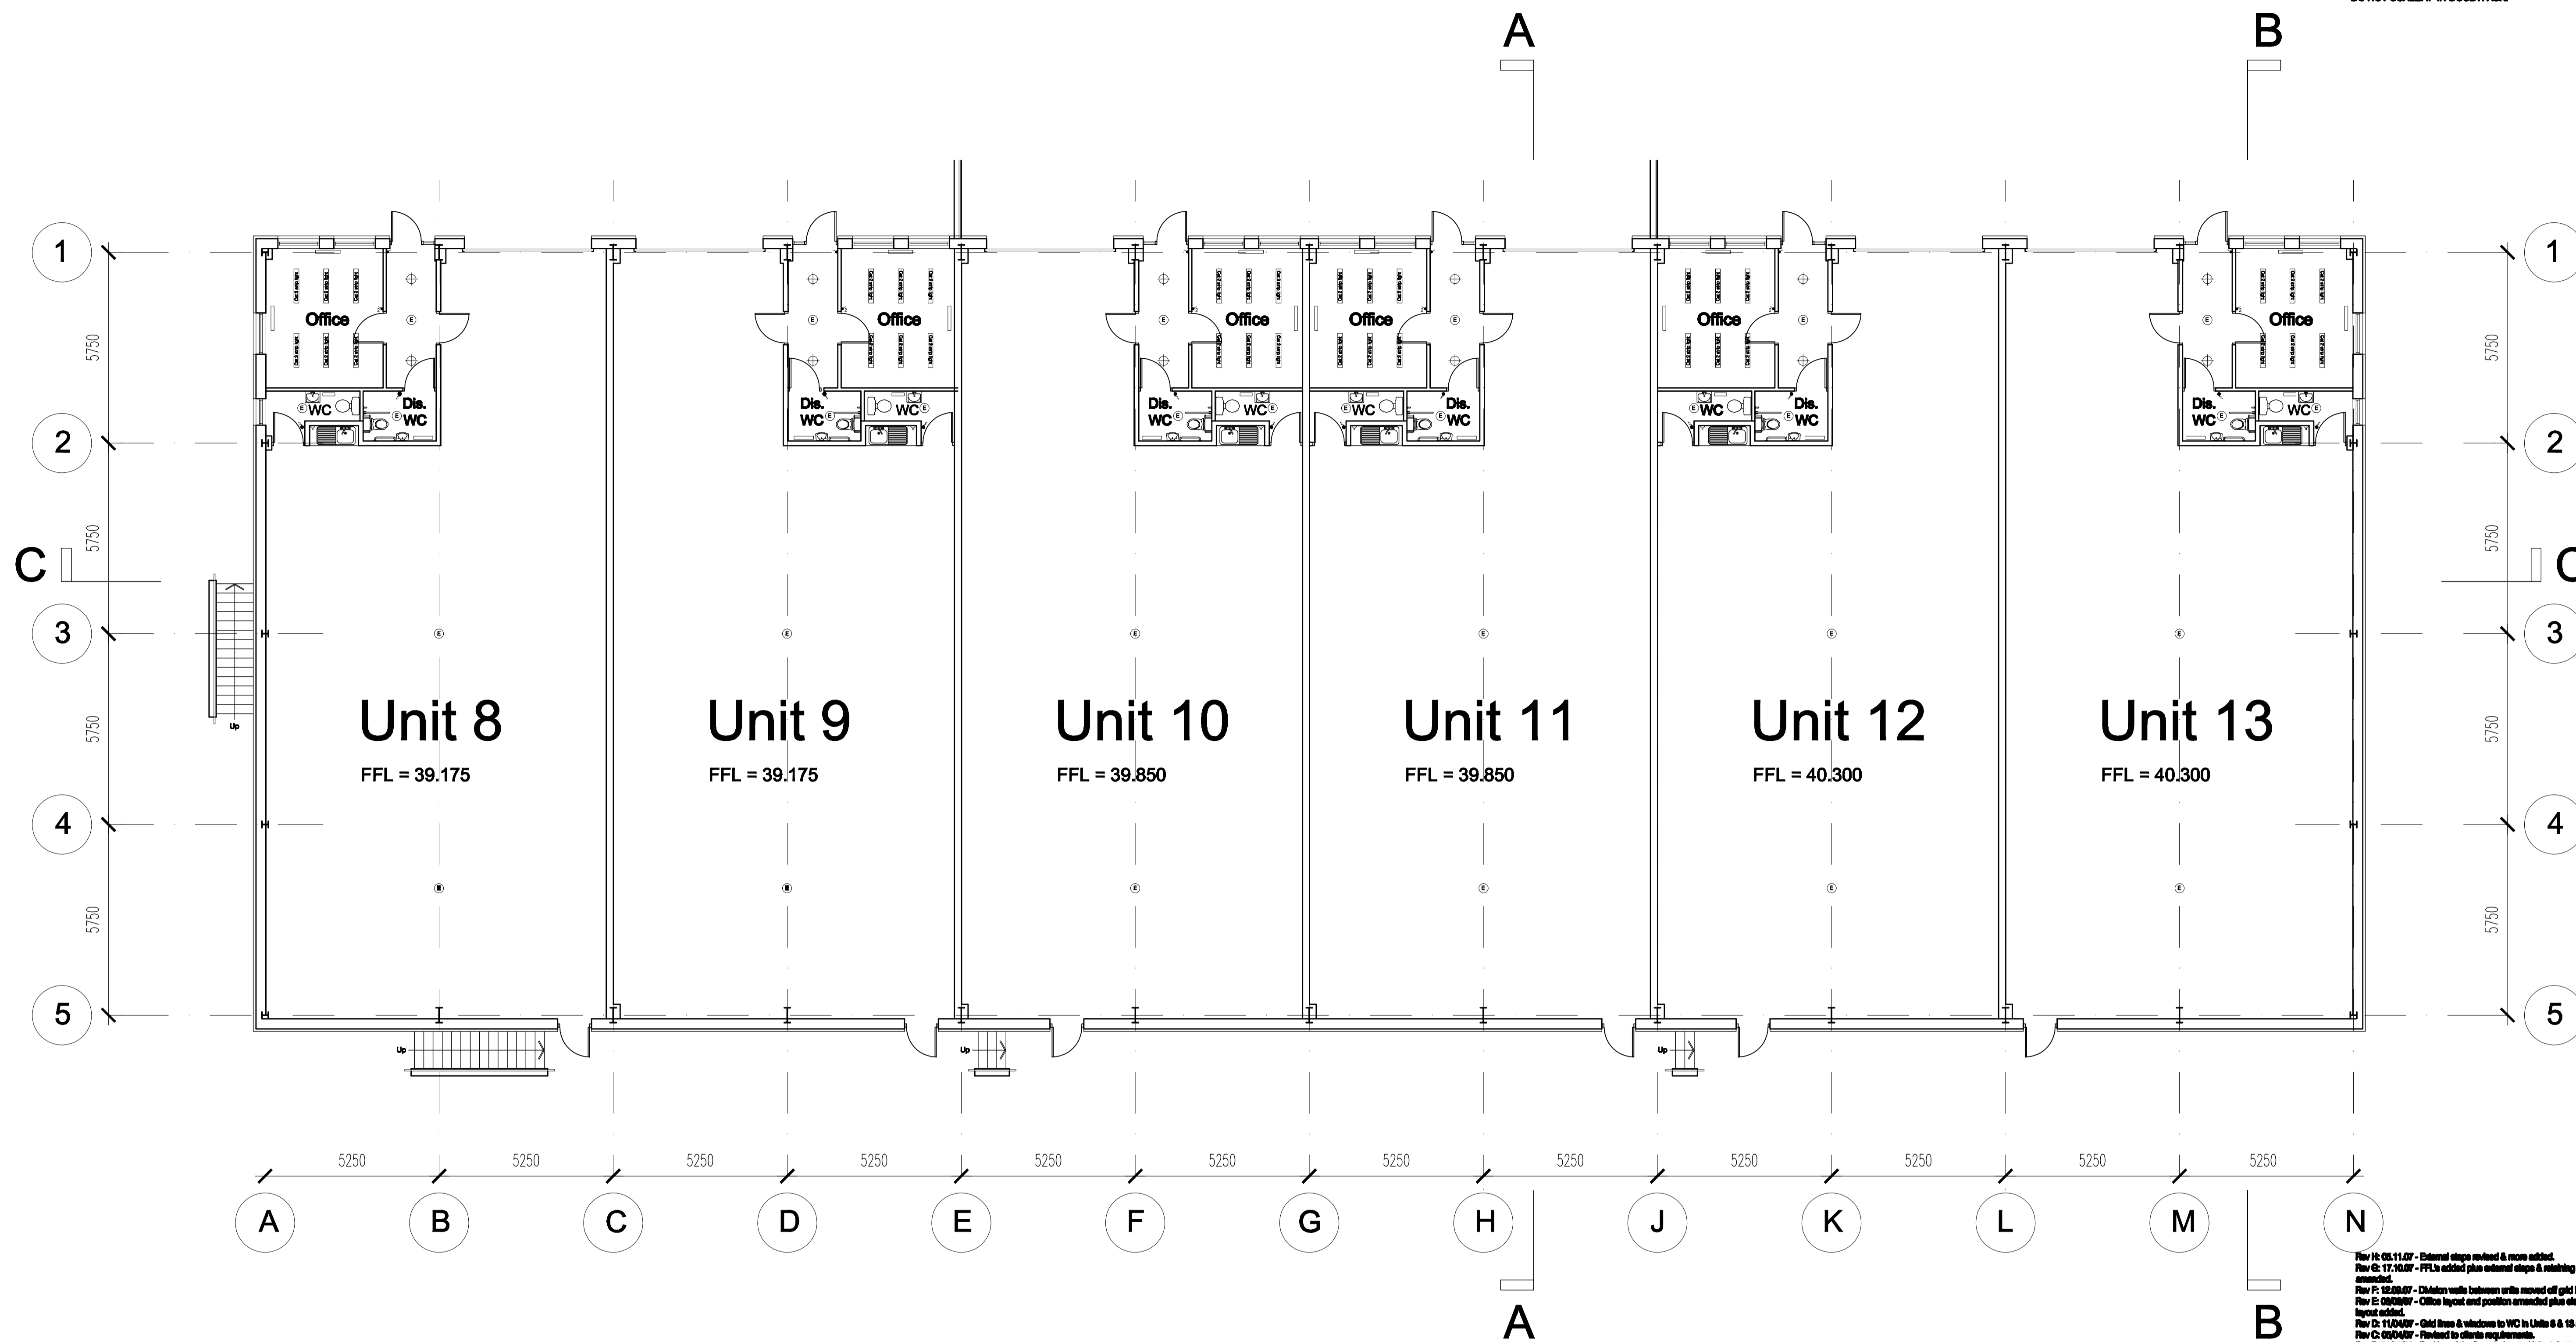


 
 




NOTES:  
DO NOT SCALE. IF IN DOUBT, ASK.



Ground Floor Plan

Key

-  Emergency lighting
-  Single Pendant light point (low energy lamp)
-  Atlantic Heater
-  Double switched socket
-  Single light switch
-  Single light pull cord

- Rev H: 05.11.07 - External steps revised & memo added.
- Rev G: 17.10.07 - FFLs added plus external steps & retaining walls amended.
- Rev F: 12.09.07 - Disabled walls between units moved off grid line.
- Rev E: 08.09.07 - Office layout and position amended plus electric layout added.
- Rev D: 11.04.07 - Grid lines & windows to WC in Units 8 & 10 amended.
- Rev C: 09.04.07 - Revised to clients requirements.
- Rev B: 01.02.07 - Position of fire exit door to Units 8 & 11 amended.
- Rev A: 24.04.06 - Layout amended plus gridlines & dimensions added.

Client  
**D. Noble Ltd.**

Project  
**Plot 11  
Grimethorpe**

Drawing  
**Block B Proposed Ground Floor  
Plan**



Unit 11 South West Centre  
Troutbeck Road, Sheffield S7 2QA  
E-mail: design@selfarchitects.co.uk  
tel. 0114 290 8800  
fax. 0114 295 8800

Drawn by <b>art</b>	Date <b>April 06</b>	Scale <b>1:100 @ A1</b>
Checked by <b>No. 3279-09</b>	Rev. <b>H</b>	